
 

 
 
 
 

 
 
 
 
 
 
 



 

 
 

 


 
 
 



 


## LIGHTING FIXTURE SCHEDULE

PROVIDED FOR INFORMATION ONLY.  
VERIFY AND INSTALL PER ELECTRICAL DRAWING

 
 
 
 
 
 


 
 

 
 

 
 
01-11-19

ITEM	SYMBOL	DESCRIPTION	QTY.	MFR. & CAT. NO.	REMARK
<b>INTERIOR LIGHTING ITEM</b>					
		T-BAR CEILING RECESSED MOUNTED LED LIGHTING FIXTURE, 2' X 4', 120V BAKED-ON WHITE ENAMEL FINISH.	10	LSI FIXTURE: SFP24-LED-FS-UNV-DIM	KITCHEN CEILING LIGHTS, FURNISHED BY OWNER INSTALLED BY GC
		T-BAR CEILING RECESSED MOUNTED LED LIGHTING FIXTURE, 2' X 2', 120V BAKED-ON WHITE ENAMEL FINISH.	1	LSI FIXTURE: SFP22-LED-FS-UNV-DIM	KITCHEN CEILING LIGHTS, FURNISHED BY OWNER INSTALLED BY GC
		T-BAR CEILING RECESSED MOUNTED LED LIGHTING FIXTURE, 1' X 4', 120V BAKED-ON WHITE ENAMEL FINISH.	2	LSI FIXTURE: SFP14-LED-FS-UNV-DIM	KITCHEN CEILING LIGHTS, FURNISHED BY OWNER INSTALLED BY GC
		T-BAR CEILING RECESSED MOUNTED LED LIGHTING EMERGENCY FIXTURE, 2' X 4', 120V BAKED-ON WHITE ENAMEL FINISH.	4	LSI FIXTURE: SFP24-LED-FS-UNV-DIM-EM	EMERGENCY KITCHEN CEILING LIGHTS FURNISHED BY OWNER INSTALLED BY GC
		UNIVERSAL MOUNT EXIT SIGN, LED LIGHTED, 120/277V WITH BATTERY PACK, 2 FACE, GREEN LETTER	4	EXITRONIX GVEK-U-BP-WB-BL-R6	EXIT SIGN FURNISHED BY OWNER, INSTALLED BY GC
		HOOD LIGHT	12	FURNISHED & INSTALLED BY EQUIPMENT SUPPLIER	LIGHTS SUPPLIED & PRE-WIRED BY HOOD VENDOR. ELECTRIC CONTRACTOR TO CONNECT MAIN WIRES TO SHUNT TRIP BREAKER AND HOOD CONTROL PANEL
		WALK-IN COOLER FLUORESCENT LIGHT, 120 V 48"	3	KASON FIXTURE: # 1810LX4000	FURNISHED BY WIC VENDOR, G.R.E. , INSTALLED BY GC
		DOWN LIGHT, RECESSED IN CEILING	45	ELITE HOUSING: LD6IC-AT LED MODULE: ELITE LED LIGHTING RL607-750L-DIMTR-120-30K-SN-SN-90+	FURNISHED BY OWNER, INSTALLED BY GC
		EMERGENCY DOWN LIGHT, RECESSED IN CEILING	6	ELITE HOUSING: LD6IC-AT LED MODULE: ELITE LED LIGHTING RL607-750L-DIMTR-120-30K-SN-SN-90+	EMERGENCY RECESSED DOWN LIGHT - NORMALLY ON INVERTER UNIT - ISOLITE, IMI-12LC-V1 FURNISHED BY OWNER INSTALLED BY GC
		3 3/4" ADJUSTABLE MR16 DOWN LIGHT, RECESSED IN CEILING. "W" SHALL DESIGNATE WHITE TRIM USED FOR MENU BD. SOFFIT	10	LIGHTLOTIER: LYTECASTER-378WHX FRAME-IN KIT: 302MRSPX BULB: MR16 - GE - PRECISE IR 37 WATT 40 ° BEAM	FURNISHED BY OWNER, INSTALLED BY GC
		3 3/4" ADJUSTABLE MR16 DOWN LIGHT, RECESSED IN CEILING. "B" SHALL DESIGNATE BLACK TRIM USED FOR DINING ROOM CEILING GRID	5	LIGHTLOTIER: LYTECASTER-378WHX FRAME-IN KIT: 302MRSPX BULB: MR16 - GE - PRECISE IR 37 WATT 40 ° BEAM	FURNISHED BY OWNER, INSTALLED BY GC
		WHITE LED AT SERVICE COUNTER SOFFIT & DINING ROOM PARTIAL HEIGHT WALL	60 L.F.	LUXEM BRIGHT FIXTURE: BLAZE LED	FURNISHED BY OWNER, INSTALLED BY GC
		WHITE LED AT MURAL LIGHT COVE	60 L.F.	NOVA FLEX - PRO SERIES FIXTURE: BENDABLE 3916	FURNISHED BY OWNER, INSTALLED BY GC
		12" DIA. DECORATIVE MORILL PENDANT LF INCANDESCENT	3	LBL LIGHTING, MODEL # 6227801-839 BULB: LED EDISON LAMP.1173467	FURNISHED BY OWNER, INSTALLED BY GC
		MICRO INVERTER	1	ISOLITE #IMI 125	FURNISHED BY OWNER, INSTALLED BY GC
		17.3" DIA. RED CUPOLA PENDANT	6	H-LITE, MODEL #H-VLPDM3-RDMT	FURNISHED BY OWNER, INSTALLED BY GC
		SPEAKER	-	-	FURNISHED BY MUSIC VENDOR, INSTALLED BY MUSIC VENDOR

NIGHT LIGHTING REQUIREMENTS: "NL" DESIGNATION INDICATED NIGHT LIGHT ON UNSWITCHED CIRCUIT.

1. ONE NL BY SERVICE COUNTER, POS / CASHIER
2. ONE NL BY POS / CASHIER AT DRIVE THRU STATION IF APPLICABLE
3. ONE NL BY EACH EXIT DOORS IN DINNING ROOM & BACK OF HOUSE


## EXTERIOR LIGHTING

		LINEAR LIGHT AT EXTERIOR STORAGE ROOM	1	COOPER MX-4VT2-LD4-6-DR-UNV-L840-CD1-WL-U	FURNISHED BY OWNER, INSTALLED BY GC
		WALL MOUNTED OVER SERVICE DOOR FIXTURE	1	HOWARD: VL305 30W LED, BRONZE	OVER EXTERIOR SERVICE DOOR. REFER ELEVATIONS FOR HEIGHT FURNISHED BY OWNER, INSTALLED BY GC
		NAVILITE EMERGENCY LIGHT	2	EXTRONIX MLED1-G-WP	OVER EXTERIOR ENTRANCE & SERVICE DOORS. REFER ELEVATIONS FOR HEIGHT. FURNISHED BY OWNER, INSTALLED BY GC
		EXTERIOR RECESS EMERGENCY LIGHT	1	ELITE HOUSING: LD6IC-AT LED MODULE: ELITE LED LIGHTING WET LOCATION: RL807-14W-120-FL-30K-SN-SN-WET LOCATION	EMERGENCY RECESSED DOWN LIGHT - NORMALLY ON INVERTER UNIT - ISOLITE, IMI-12-LC-V1 FURNISHED BY OWNER INSTALLED BY GC
		DECORATIVE LED WALL SCONCE	2	HINKLEY LIGHTING, ATLANTIS, BRONZE; 1649BZ-LED	AT PORTAL OF ENTRY DOOR. REFER ELEVATIONS FOR HEIGHT FURNISHED BY OWNER, INSTALLED BY GC
		WALL MOUNTED OVER SERVICE DOOR FIXTURE	1	HINKLEY LIGHTING, SILO, BRONZE; 13594AZ-LL; LED	OVER DRIVE THRU AREA SERVICE DOOR FURNISHED BY OWNER, INSTALLED BY GC
		LED MOTION SECURITY FLOODLIGHT	2	LITHONIA LIGHTING OLF 2RH 40K 120V MO BZ	INTERIOR LIGHT SENSOR TO BE WALL MOUNTED AT +142" FURNISHED BY OWNER, INSTALLED BY GC
		DECORATIVE LED WALL SCONCE	4	HINKLEY LIGHTING, SILO, BRONZE; 13594AZ-LL; LED	ALONG REAR EIFS BAND FURNISHED BY OWNER, INSTALLED BY GC

## CEILING SCHEDULE


INSTALLED AND FURNISHED BY, G.C. UNLESS NOTED OTHERWISE

NO	MANUFACTURER	DESCRIPTION	MATERIAL	FINISH
C1	ARMSTRONG	2' X 2' SUSPENDED T-BAR GRID CEILING SYSTEM	CUSTOM #PN91311	T-BAR AND GRID COLOR: SEPIA CONTACT AT ARMSTRONG-SHERRY BRUNT 1-900-442-4212
C2	USG	2' X 4' SUSPENDED T-BAR GRID CEILING SYSTEM	"VINYL ROCK" VINYL CLAD GYP. BD PANELS	SMOOTH AND WASHABLE WHITE
C3	GOLD BOND	MONOLITHIC CEILING ON METAL FRAMING	5/8" GYP. BD.	SMOOTH PAINT - WHITE AND WASHABLE
C4	NOT USED	-	-	-

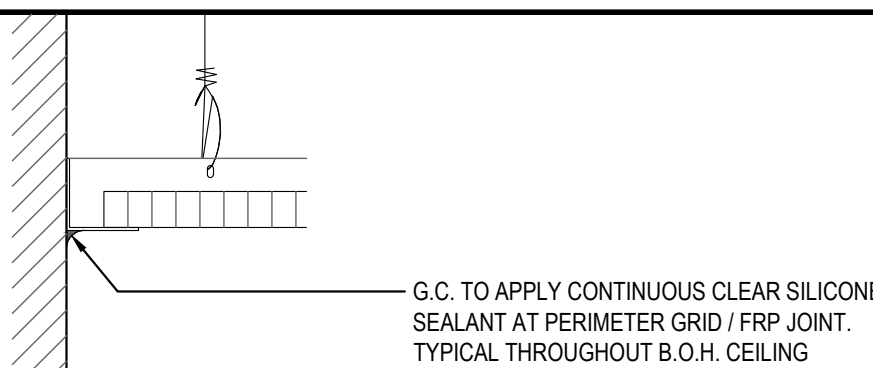


## CEILING GRID DETAIL

Scale= NTS A-105

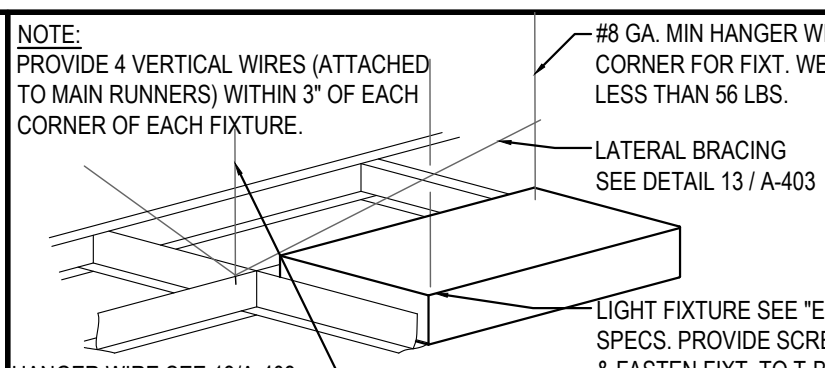

# LIGHT FIXTURE DETAIL

Scale= NTS | A-105

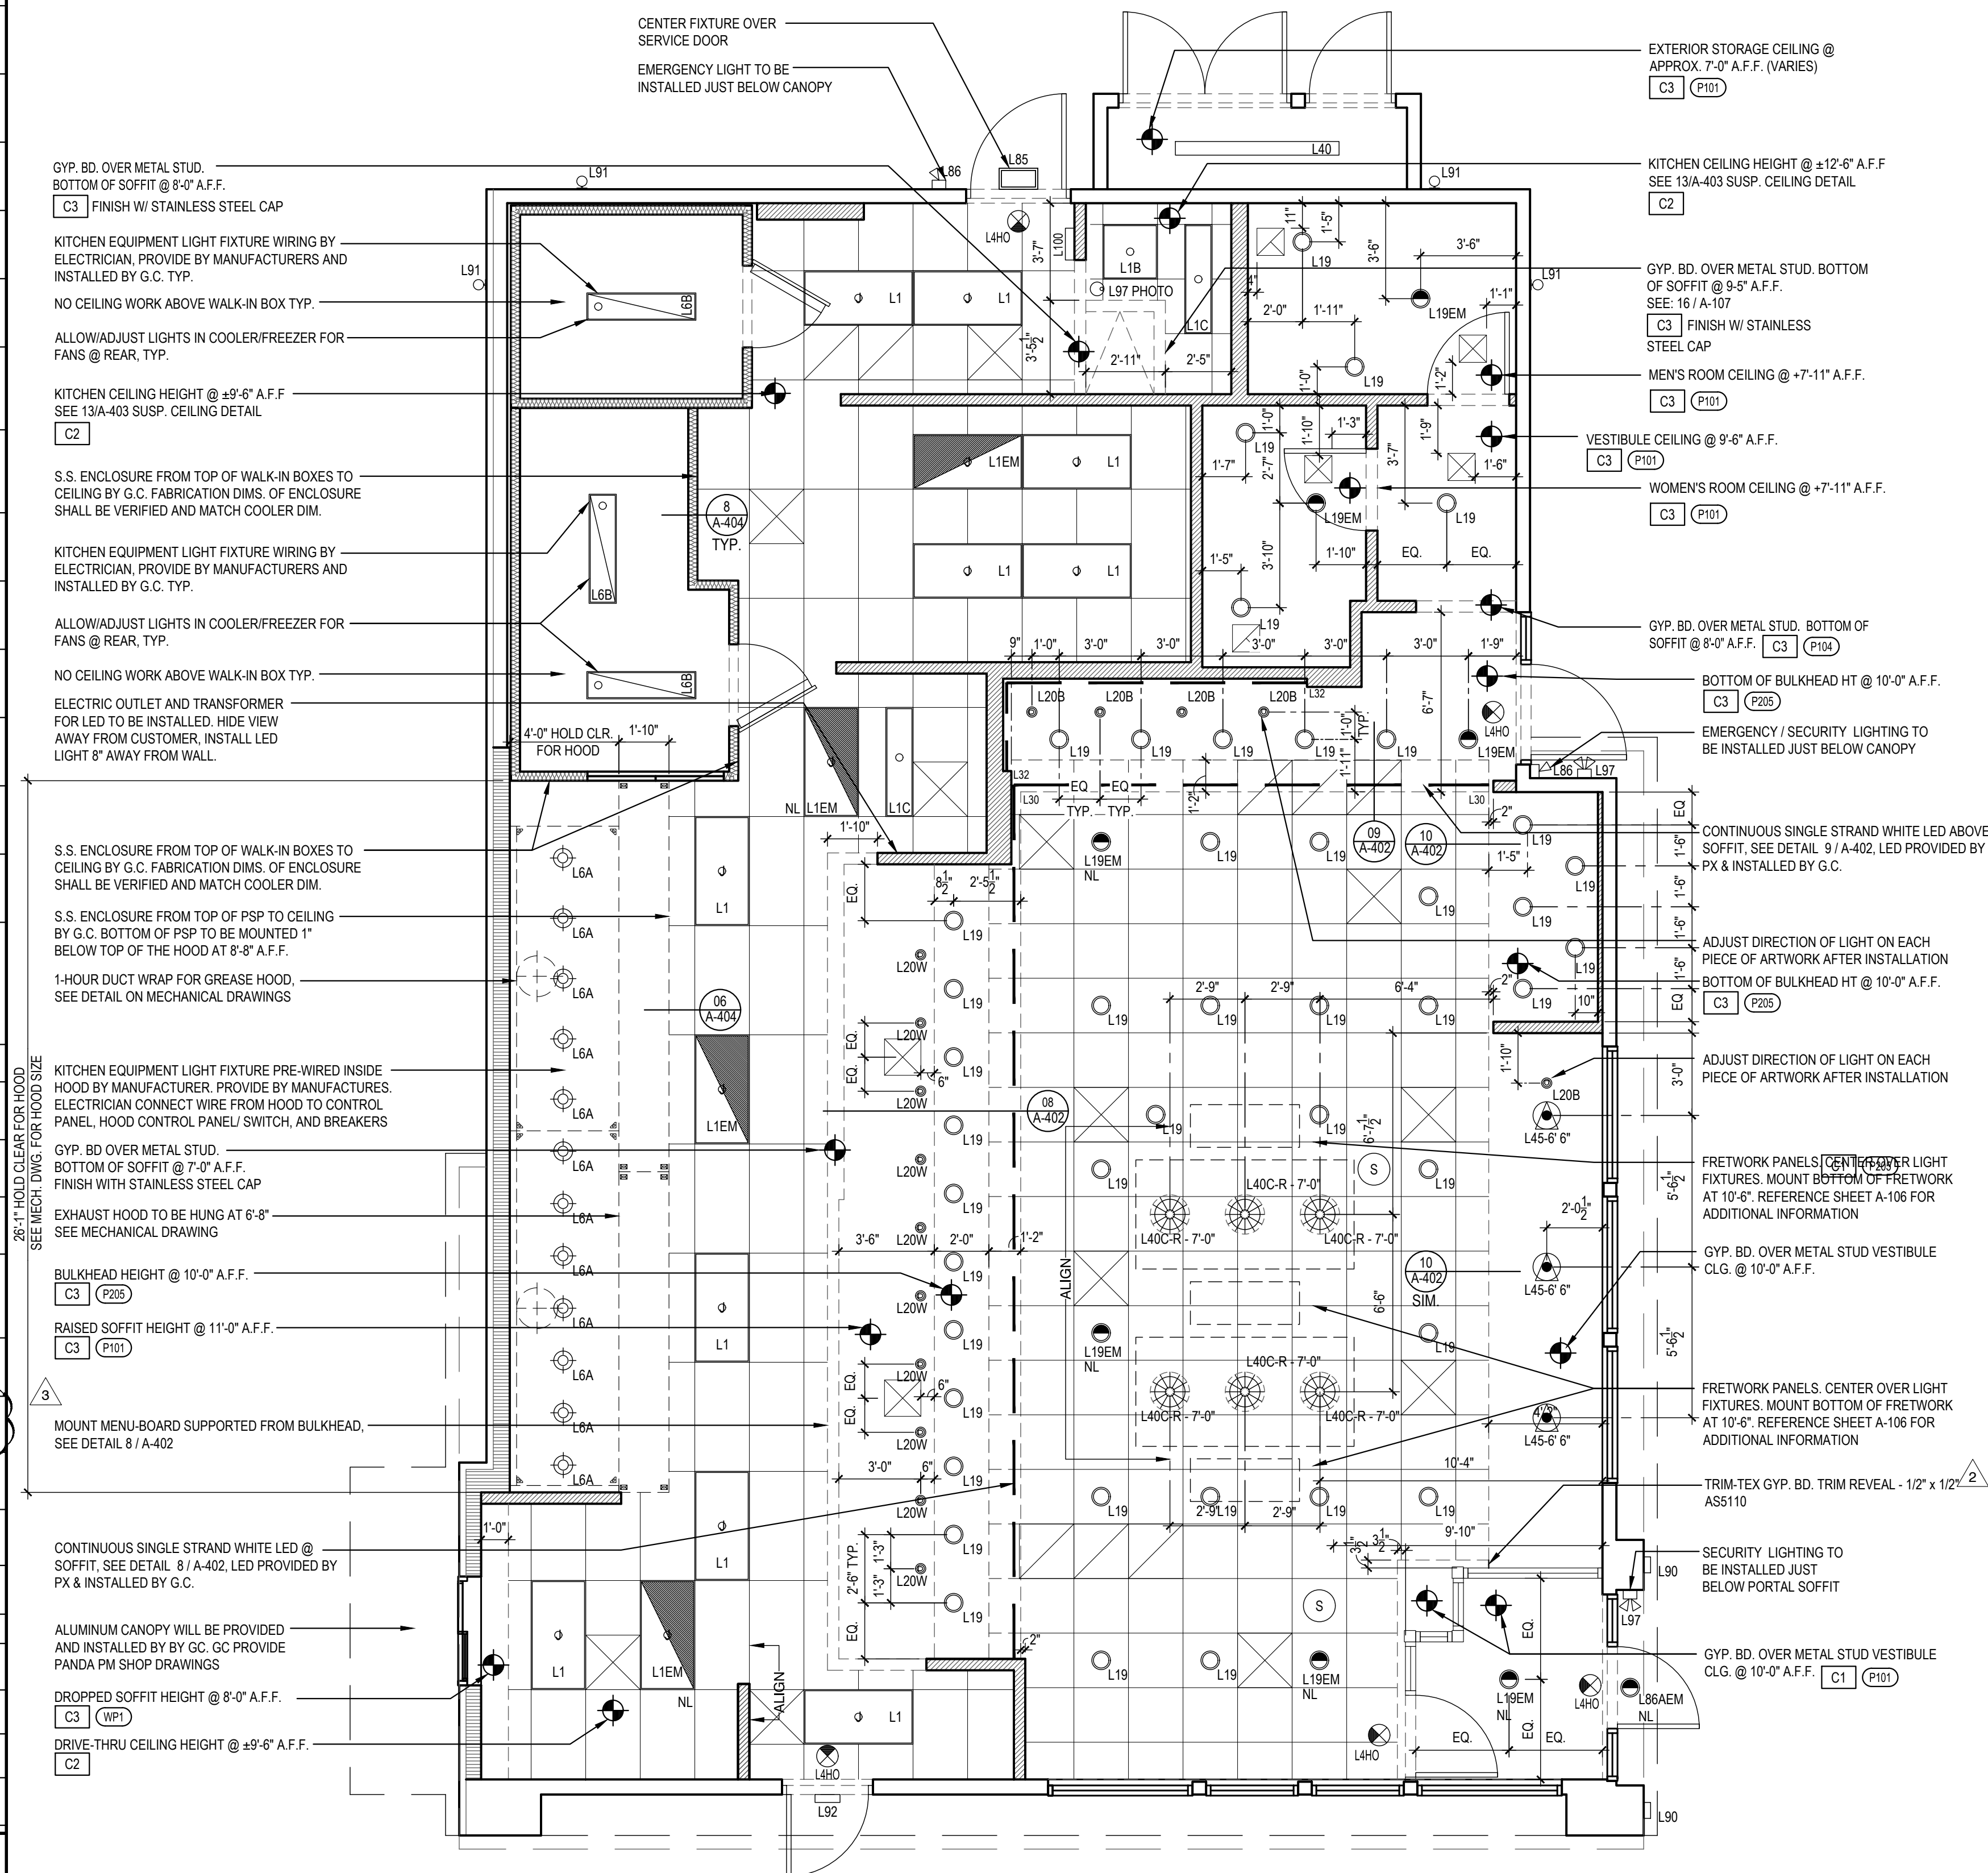

## REFLECTED CEILING PLAN (WITH VESTIBULE)

A-105

Scale= 1/4" = 1'-0"



PANDA EXPRESS, INC.  
1683 Walnut Grove Ave.  
Rosemead, California  
91770  
Telephone: 626.799.9898  
Facsimile: 626.372.8288

All ideas, designs, arrangement and plans indicated or represented by this drawing are the property of Panda Express Inc. and were created for use on this specific project. None of these ideas, designs, arrangements or plans may be used by or disclosed to any person, firm, or corporation without the written permission of Panda Express Inc.

REVISIONS:

2	SOLUTION F.2	09-30-22
3	OWNER REVISIONS	01-27-22

ISSUE DATE:


	ISSUE FOR PERMIT	01-29-2
	ISSUE FOR BID	04-30-2
	ISSUE FOR BID 2	11-02-2
	ISSUE FOR BID (DT)	02-04-2

DRAWN BY: AE


PANDA PROJECT #: D8164

PANDA STORE #:

ARCH PROJECT #: 261-321

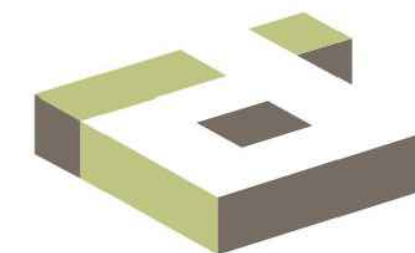

idGROUP

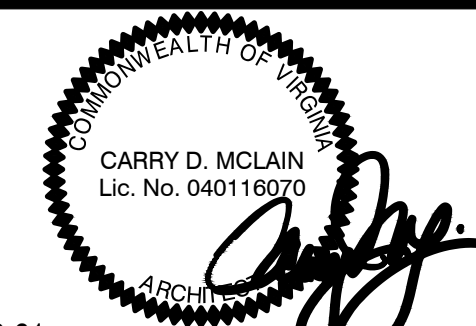

11-02-21

## PANDA EXPRESS

TRUE WARM & WELCOME  
JEFFERSON AVE. & MORRIS DR  
NEWPORT NEWS, VA 23605

# A-105

REFLECTED CEILING PLAN  
(SOLUTION F.2)

TRUE WARM & WELCOME 2300 R